


PLAN SYMBOLS AND ABBREVIATIONS

S20	FIRE DOOR KEEP CLEAR	A	LOCATION OF AREA WHERE FLAMMABLE AND/OR CHEMICAL MATERIALS ARE STORED
S24	BREAK TO OPEN	PB	PUSH BAR
S25	PUSH BAR TO OPEN	FB	FRANGIBLE BOLT
S26	DIRECTIONAL ARROW	△	WATER FIRE EXTINGUISHER
△	ELECTRICAL BREAKERS	△	CARBON DIOXIDE FIRE EXTINGUISHER
△	ILLUMINATED EXIT SIGN	△	DRY POWDER FIRE EXTINGUISHER
△	EXPULAIR UNIT	△	SELF CONTAINED EMERGENCY LIGHT

FLOOR PLAN

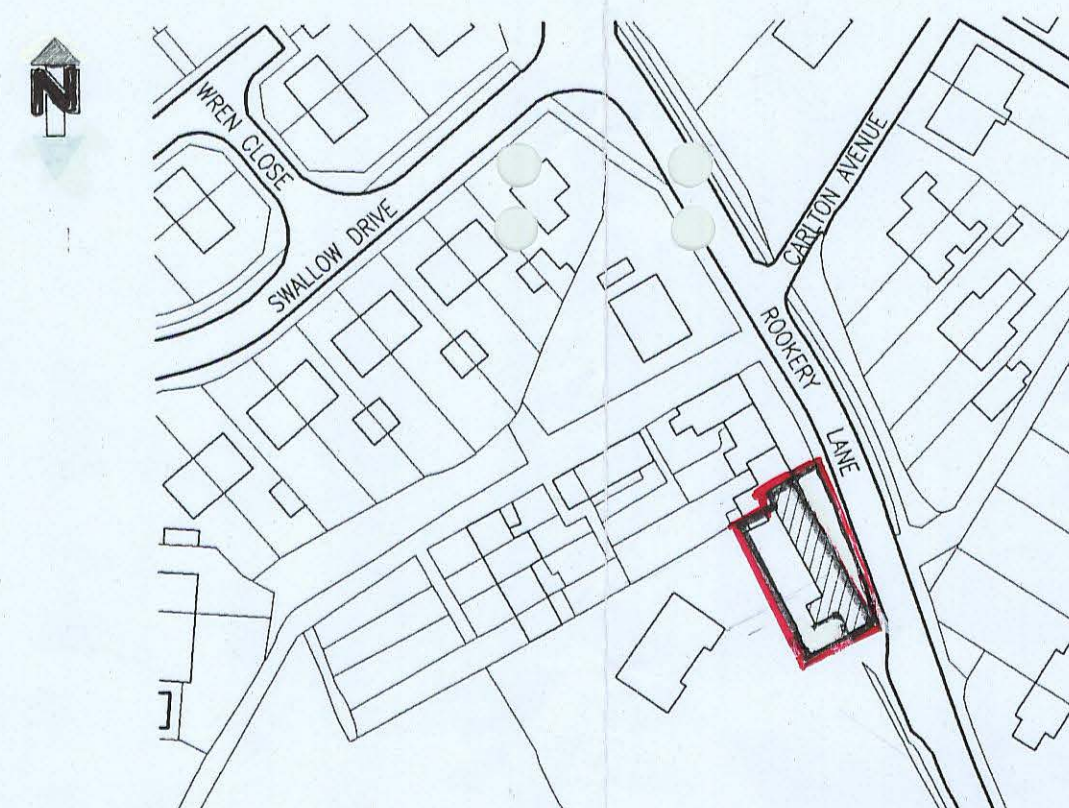

BLOCK PLAN / LOCATION PLAN

SCALE: 1/1250

NOTES

ISSUE	REVISIONS	DATE
2	REVISED FOR PLANNING APPLN.	21/01/10
1	REVISED (UPDATED)	05/01/10
0	INITIAL ISSUE	05/07/05

0 — PLOT SIZE CHECK — 100

CLIENT HEALING & DISTRICT MENS SOCIAL CLUB

DRAWING TITLE
FLOOR PLAN

SCALE 1:1250, 1:100 DATE JULY '05

PRR DRAWN TRACED CHECKED APPROVED

DRAWING NUMBER M2699/01

LIST DESIGN GROUP

CONSULTING ENGINEERS

RJA HOUSE,
MANBY ROAD,
IMMINGHAM,
SOUTH HUMBERSIDE,
DN40 2DW.

TEL. 01469 571888
FAX. 01469 571450

